



SECOND FLOOR PLAN of SCHOOL
 SCALE 1/8" = 1'-0"

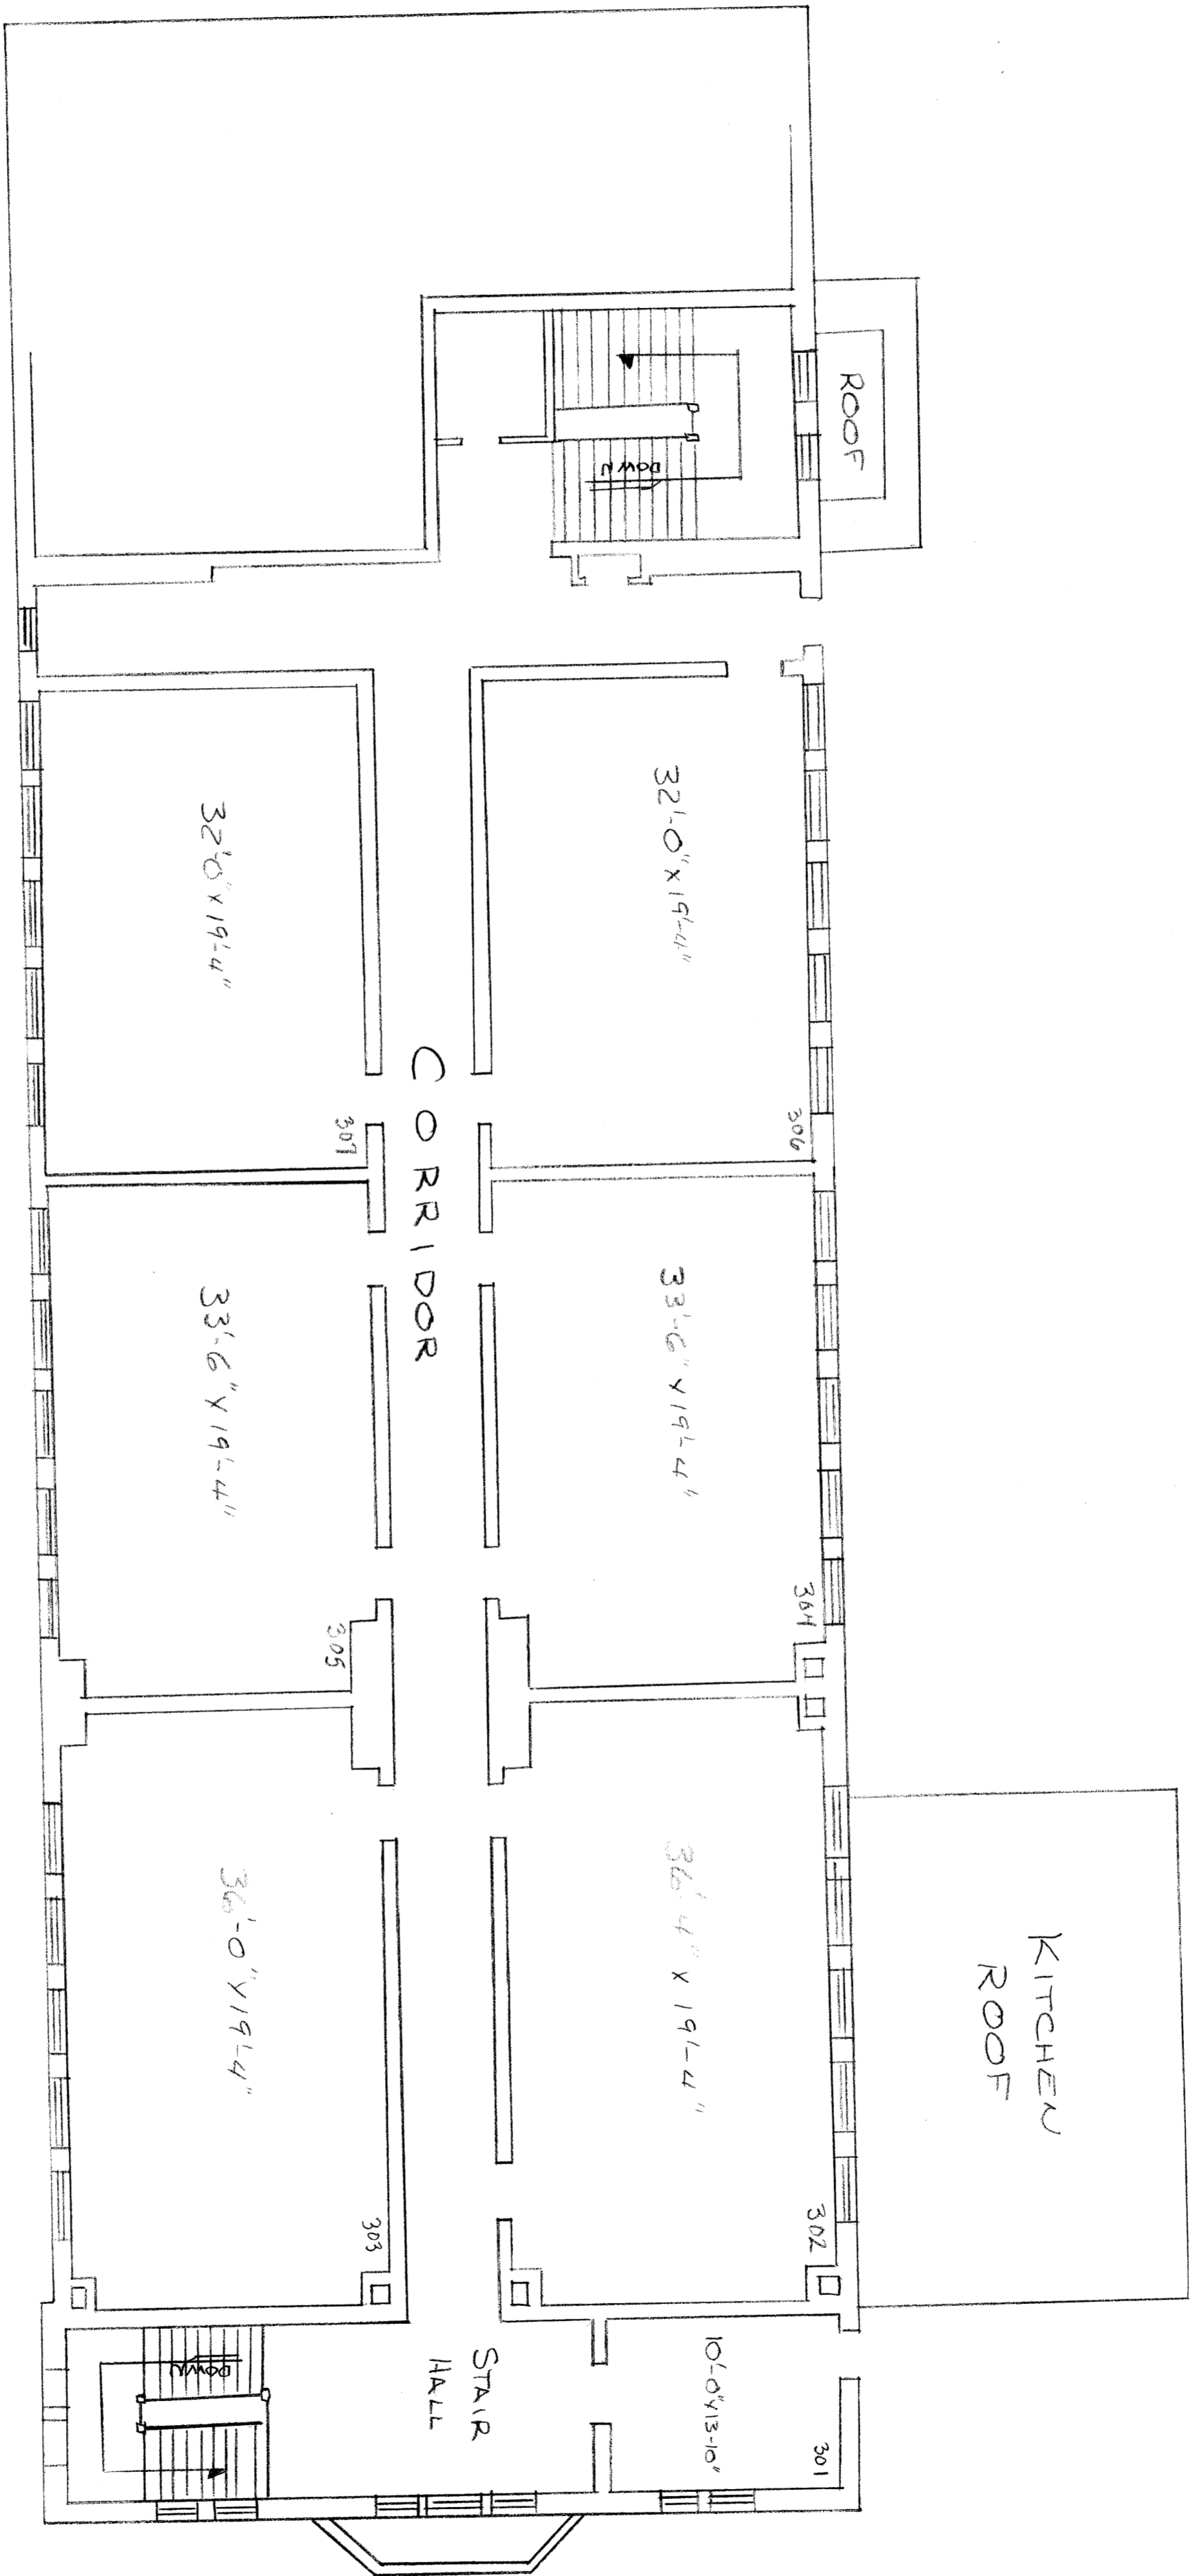

THIRD FLOOR PLAN
SCALE 1/8" = 1'-0"

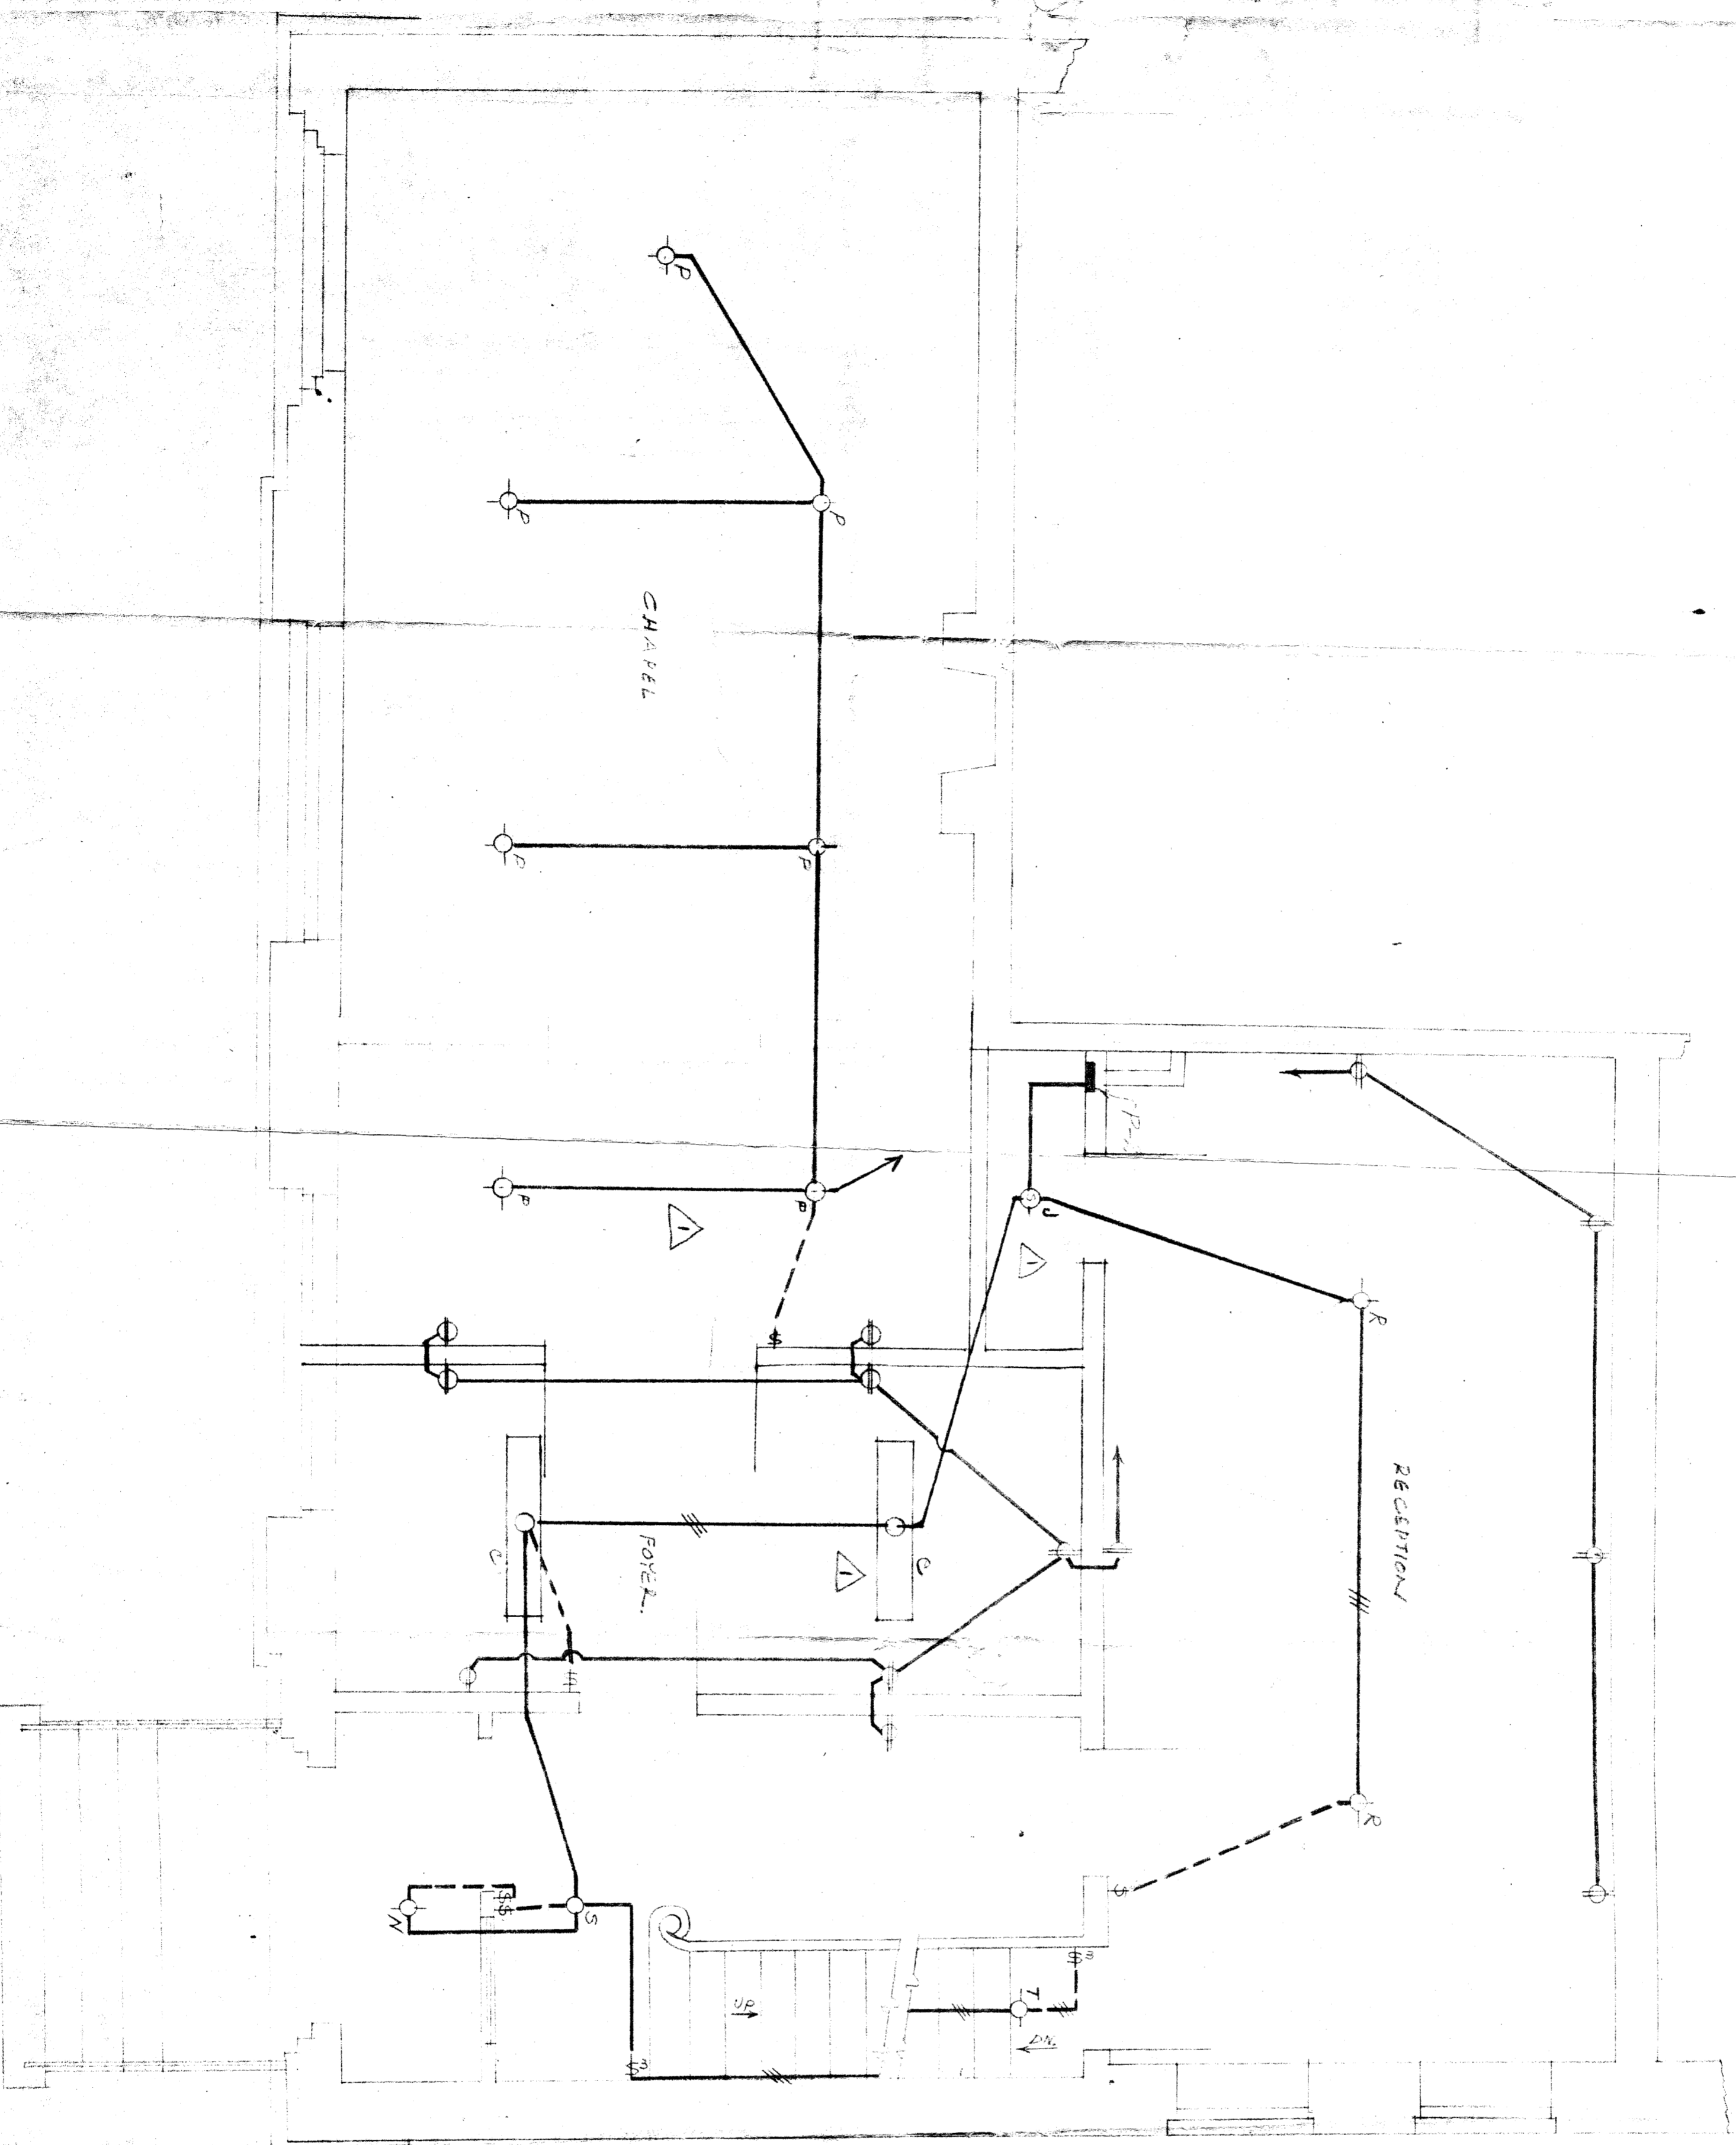


LIGHTING FIXTURES


CODE	MA.	HT.	CS.	ST.	IO.	WATTS	REMARKS
A	2' 0"	14"	10"	10"	10"	40	4' 0" FLUORESC.
B	2' 0"	14"	10"	10"	10"	40	4' 0" FLUORESC.
C	2' 0"	14"	10"	10"	10"	40	4' 0" FLUORESC.
D	2' 0"	14"	10"	10"	10"	40	4' 0" FLUORESC.
E	2' 0"	14"	10"	10"	10"	40	4' 0" FLUORESC.
F	2' 0"	14"	10"	10"	10"	40	4' 0" FLUORESC.
G	2' 0"	14"	10"	10"	10"	40	4' 0" FLUORESC.
H	2' 0"	14"	10"	10"	10"	40	4' 0" FLUORESC.
I	2' 0"	14"	10"	10"	10"	40	4' 0" FLUORESC.
J	2' 0"	14"	10"	10"	10"	40	4' 0" FLUORESC.
K	2' 0"	14"	10"	10"	10"	40	4' 0" FLUORESC.
L	2' 0"	14"	10"	10"	10"	40	4' 0" FLUORESC.
M	2' 0"	14"	10"	10"	10"	40	4' 0" FLUORESC.
N	2' 0"	14"	10"	10"	10"	40	4' 0" FLUORESC.
O	2' 0"	14"	10"	10"	10"	40	4' 0" FLUORESC.
P	2' 0"	14"	10"	10"	10"	40	4' 0" FLUORESC.
Q	2' 0"	14"	10"	10"	10"	40	4' 0" FLUORESC.
R	2' 0"	14"	10"	10"	10"	40	4' 0" FLUORESC.
S	2' 0"	14"	10"	10"	10"	40	4' 0" FLUORESC.
T	2' 0"	14"	10"	10"	10"	40	4' 0" FLUORESC.
U	2' 0"	14"	10"	10"	10"	40	4' 0" FLUORESC.
V	2' 0"	14"	10"	10"	10"	40	4' 0" FLUORESC.
W	2' 0"	14"	10"	10"	10"	40	4' 0" FLUORESC.
X	2' 0"	14"	10"	10"	10"	40	4' 0" FLUORESC.
Y	2' 0"	14"	10"	10"	10"	40	4' 0" FLUORESC.
Z	2' 0"	14"	10"	10"	10"	40	4' 0" FLUORESC.

NO.	DATE	REVISION	BY
1	10/25/51	NEW ELECTRICAL SYMBOLS ADDED IN CHAPEL AND RECEPTION REVISION IN 1951K.	E.J.T.


ELECTRICAL FIRST FLOOR		SCALE 3/8" = 1'-0"
ALTERATIONS TO SAINT PATRICK'S CONVENT 270 SHEPHERD STREET ALBANY, N.Y.		DRAWN E.E.
EDWARD J. TOOLE ARCHITECT 52 NORTH PEARL ST. ALBANY, N.Y.		CHECKED
DATE 10/25/51	SHEET 10	APPROVED
JOB	OFFICE	

FIRST FLOOR PLAN of SCHOOL
SCALE 1/8" = 1'-0"

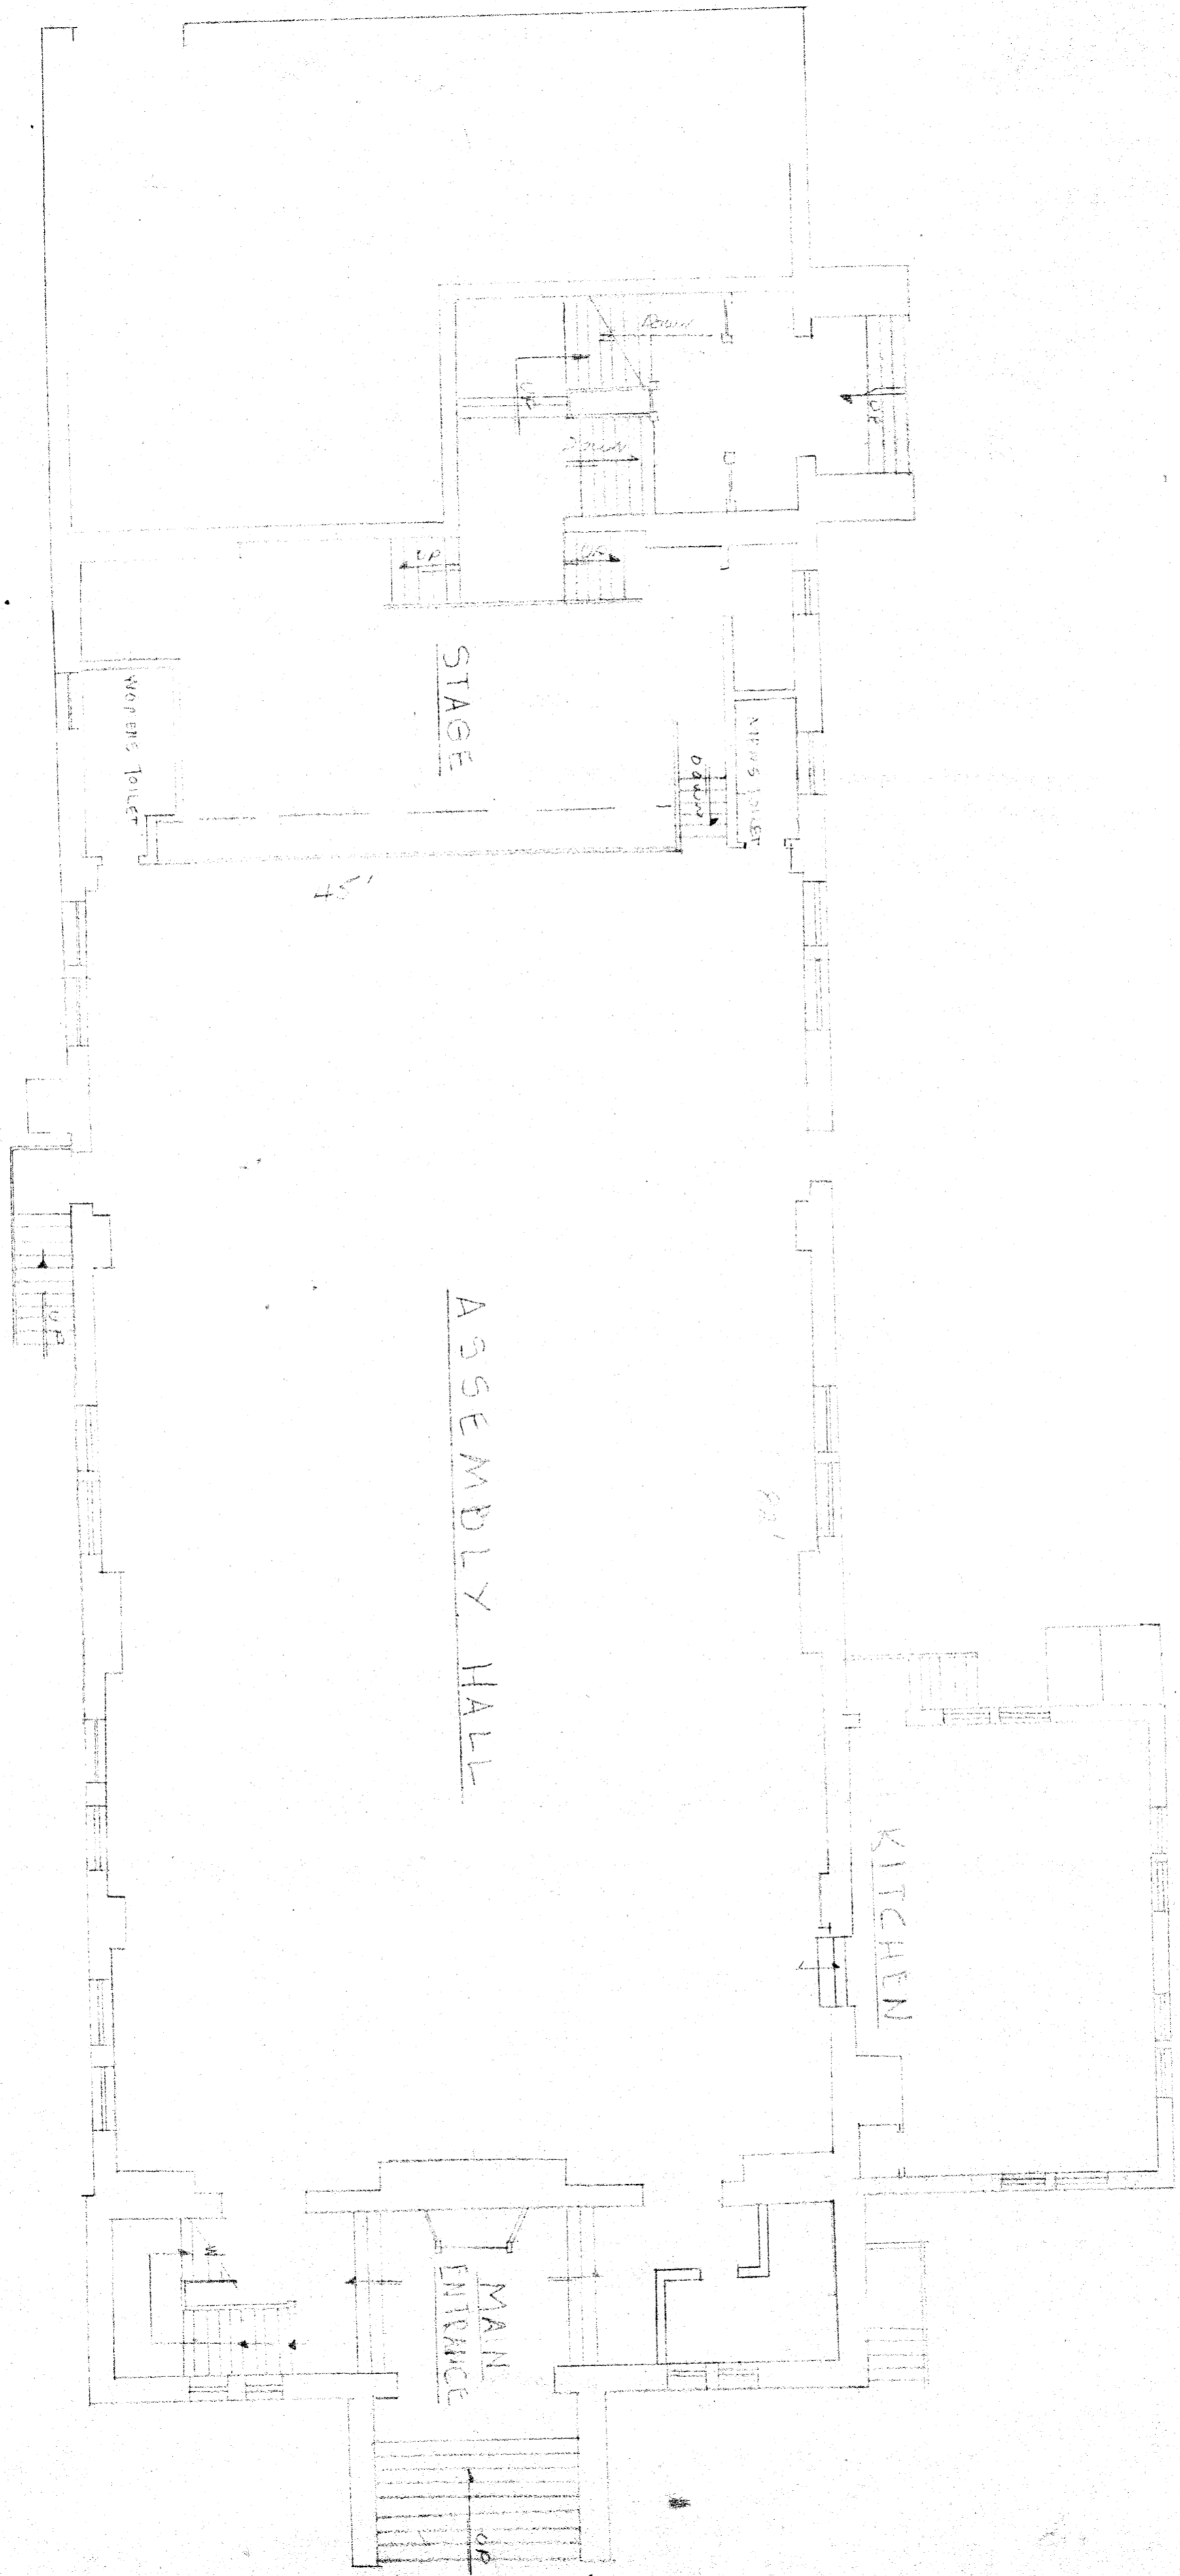

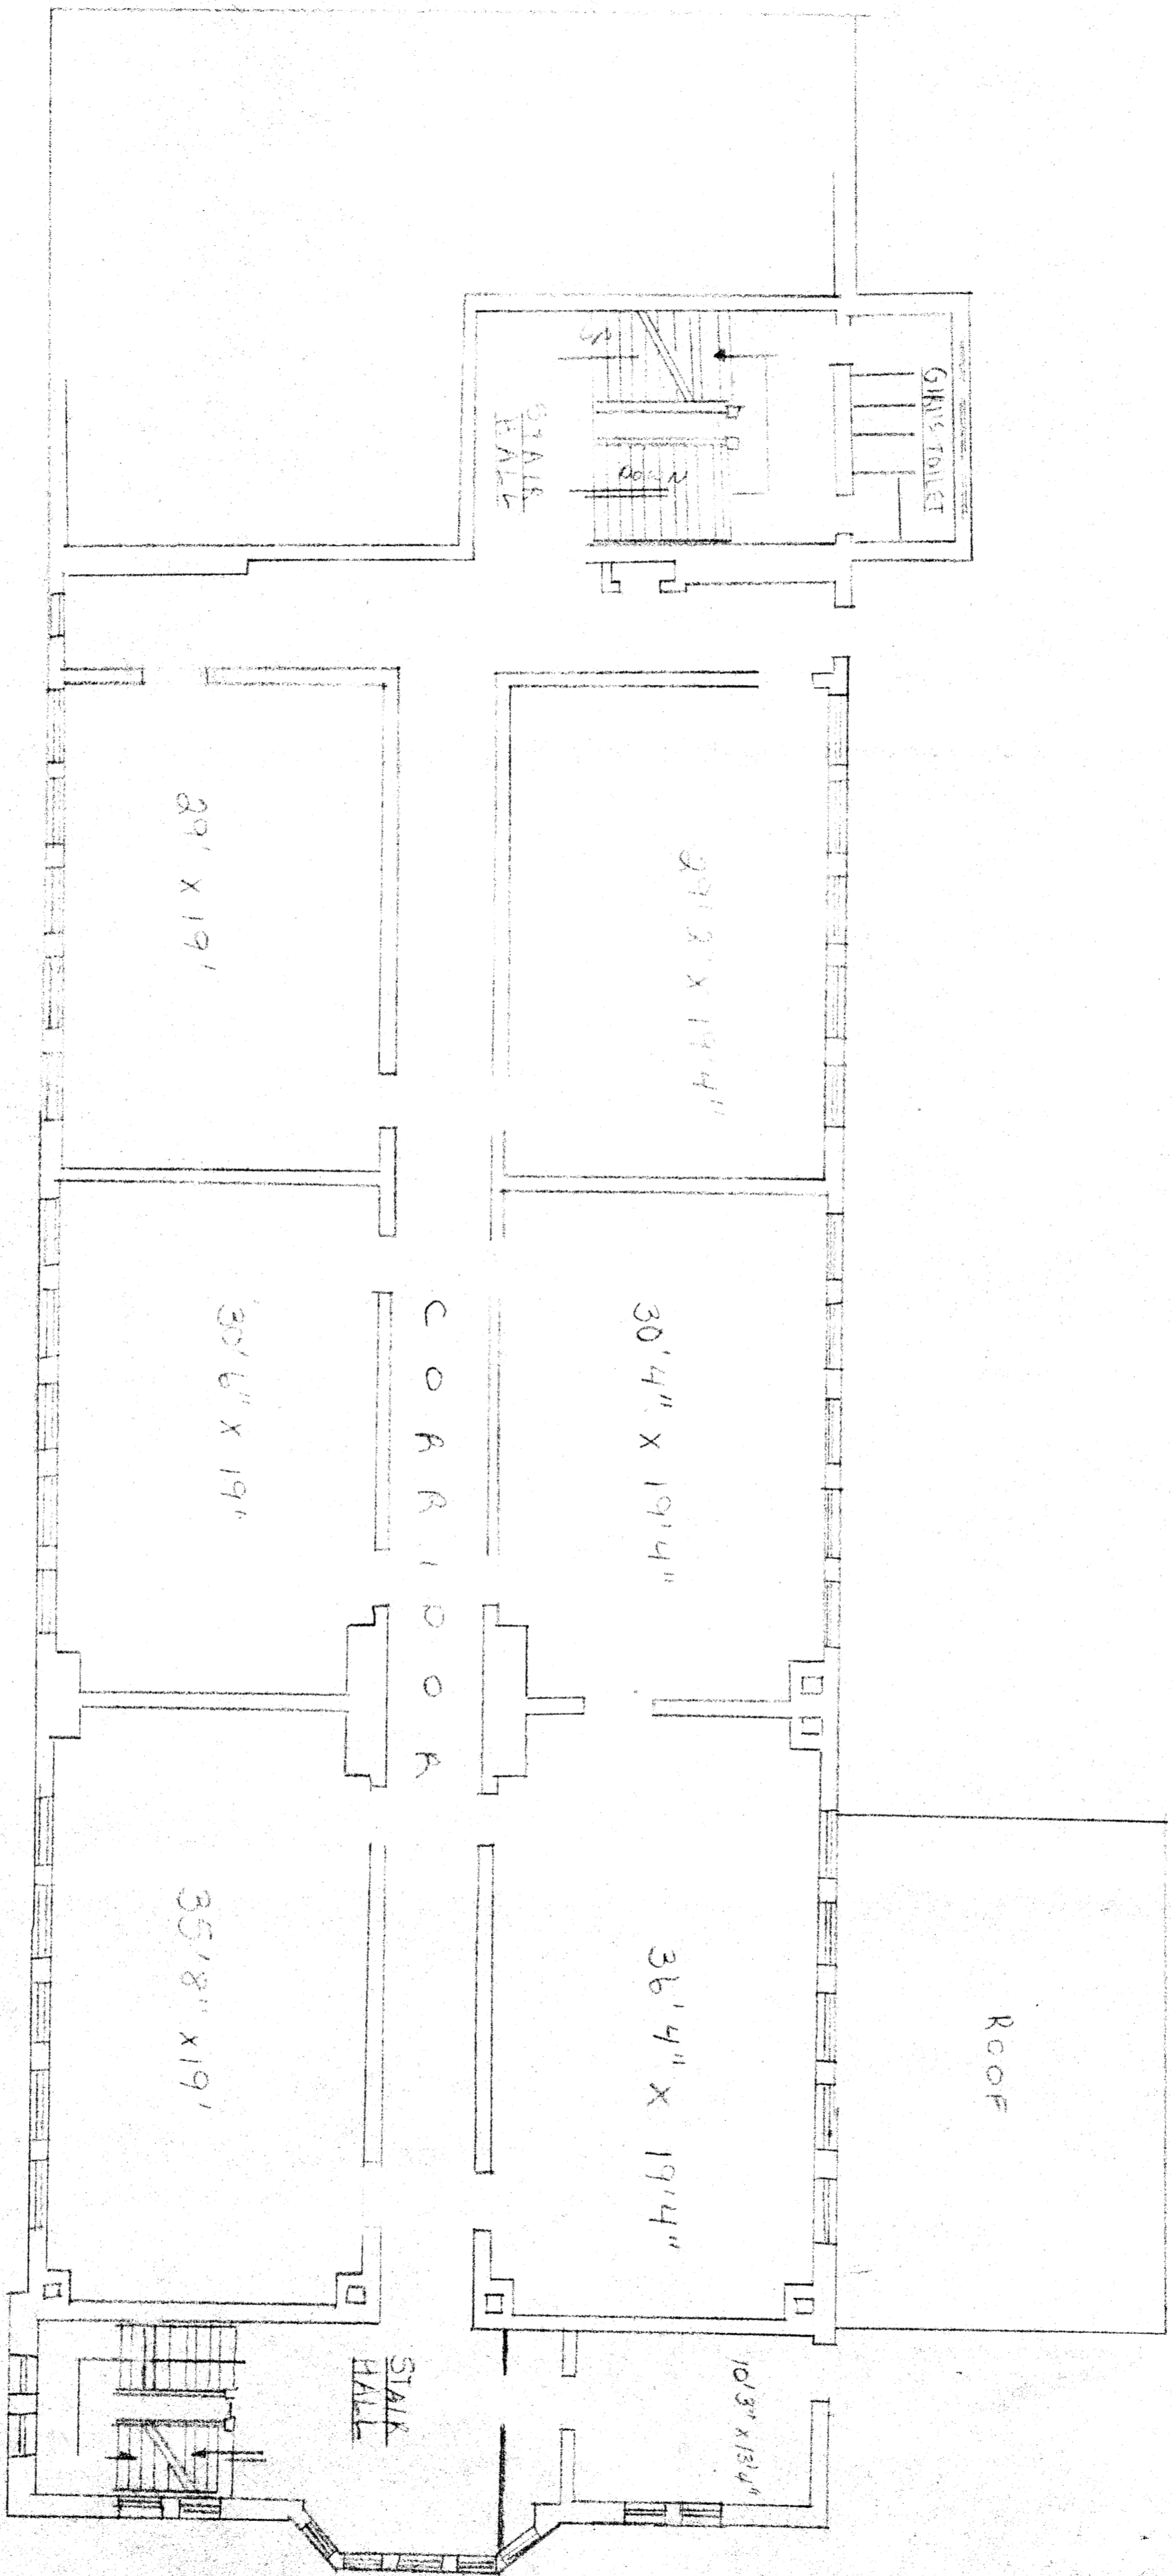


SECOND FLOOR PLAN of SCHOOL
 SCALE 1/8" = 1'-0"

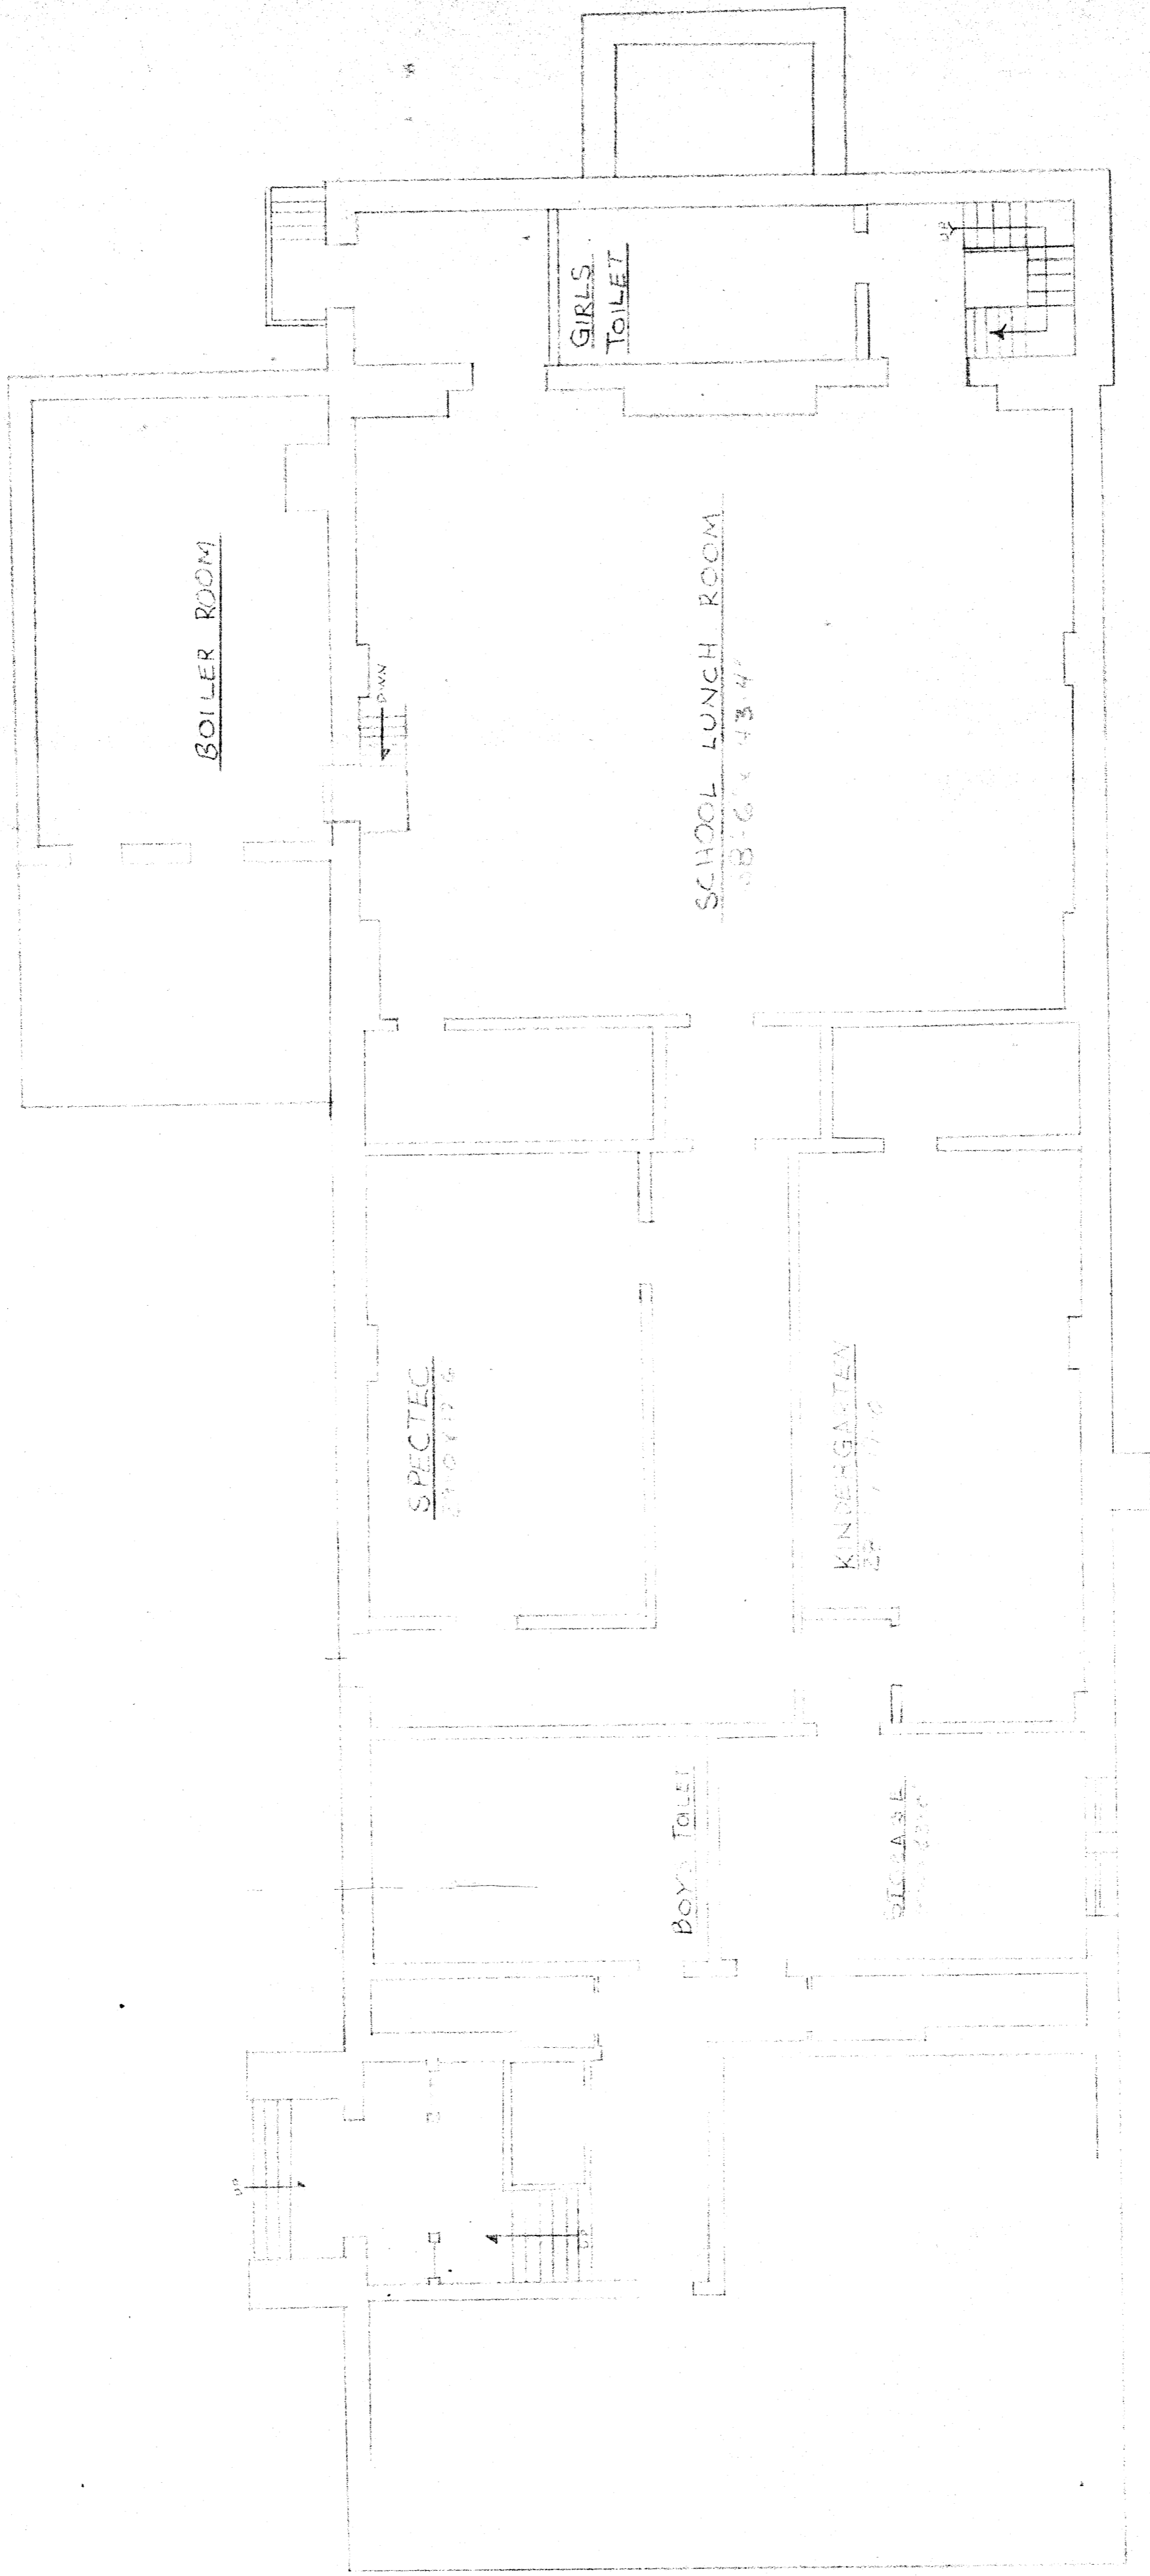

BASEMENT PLAN OF SCHOOL

SCALE 3/8" = 1'-0"

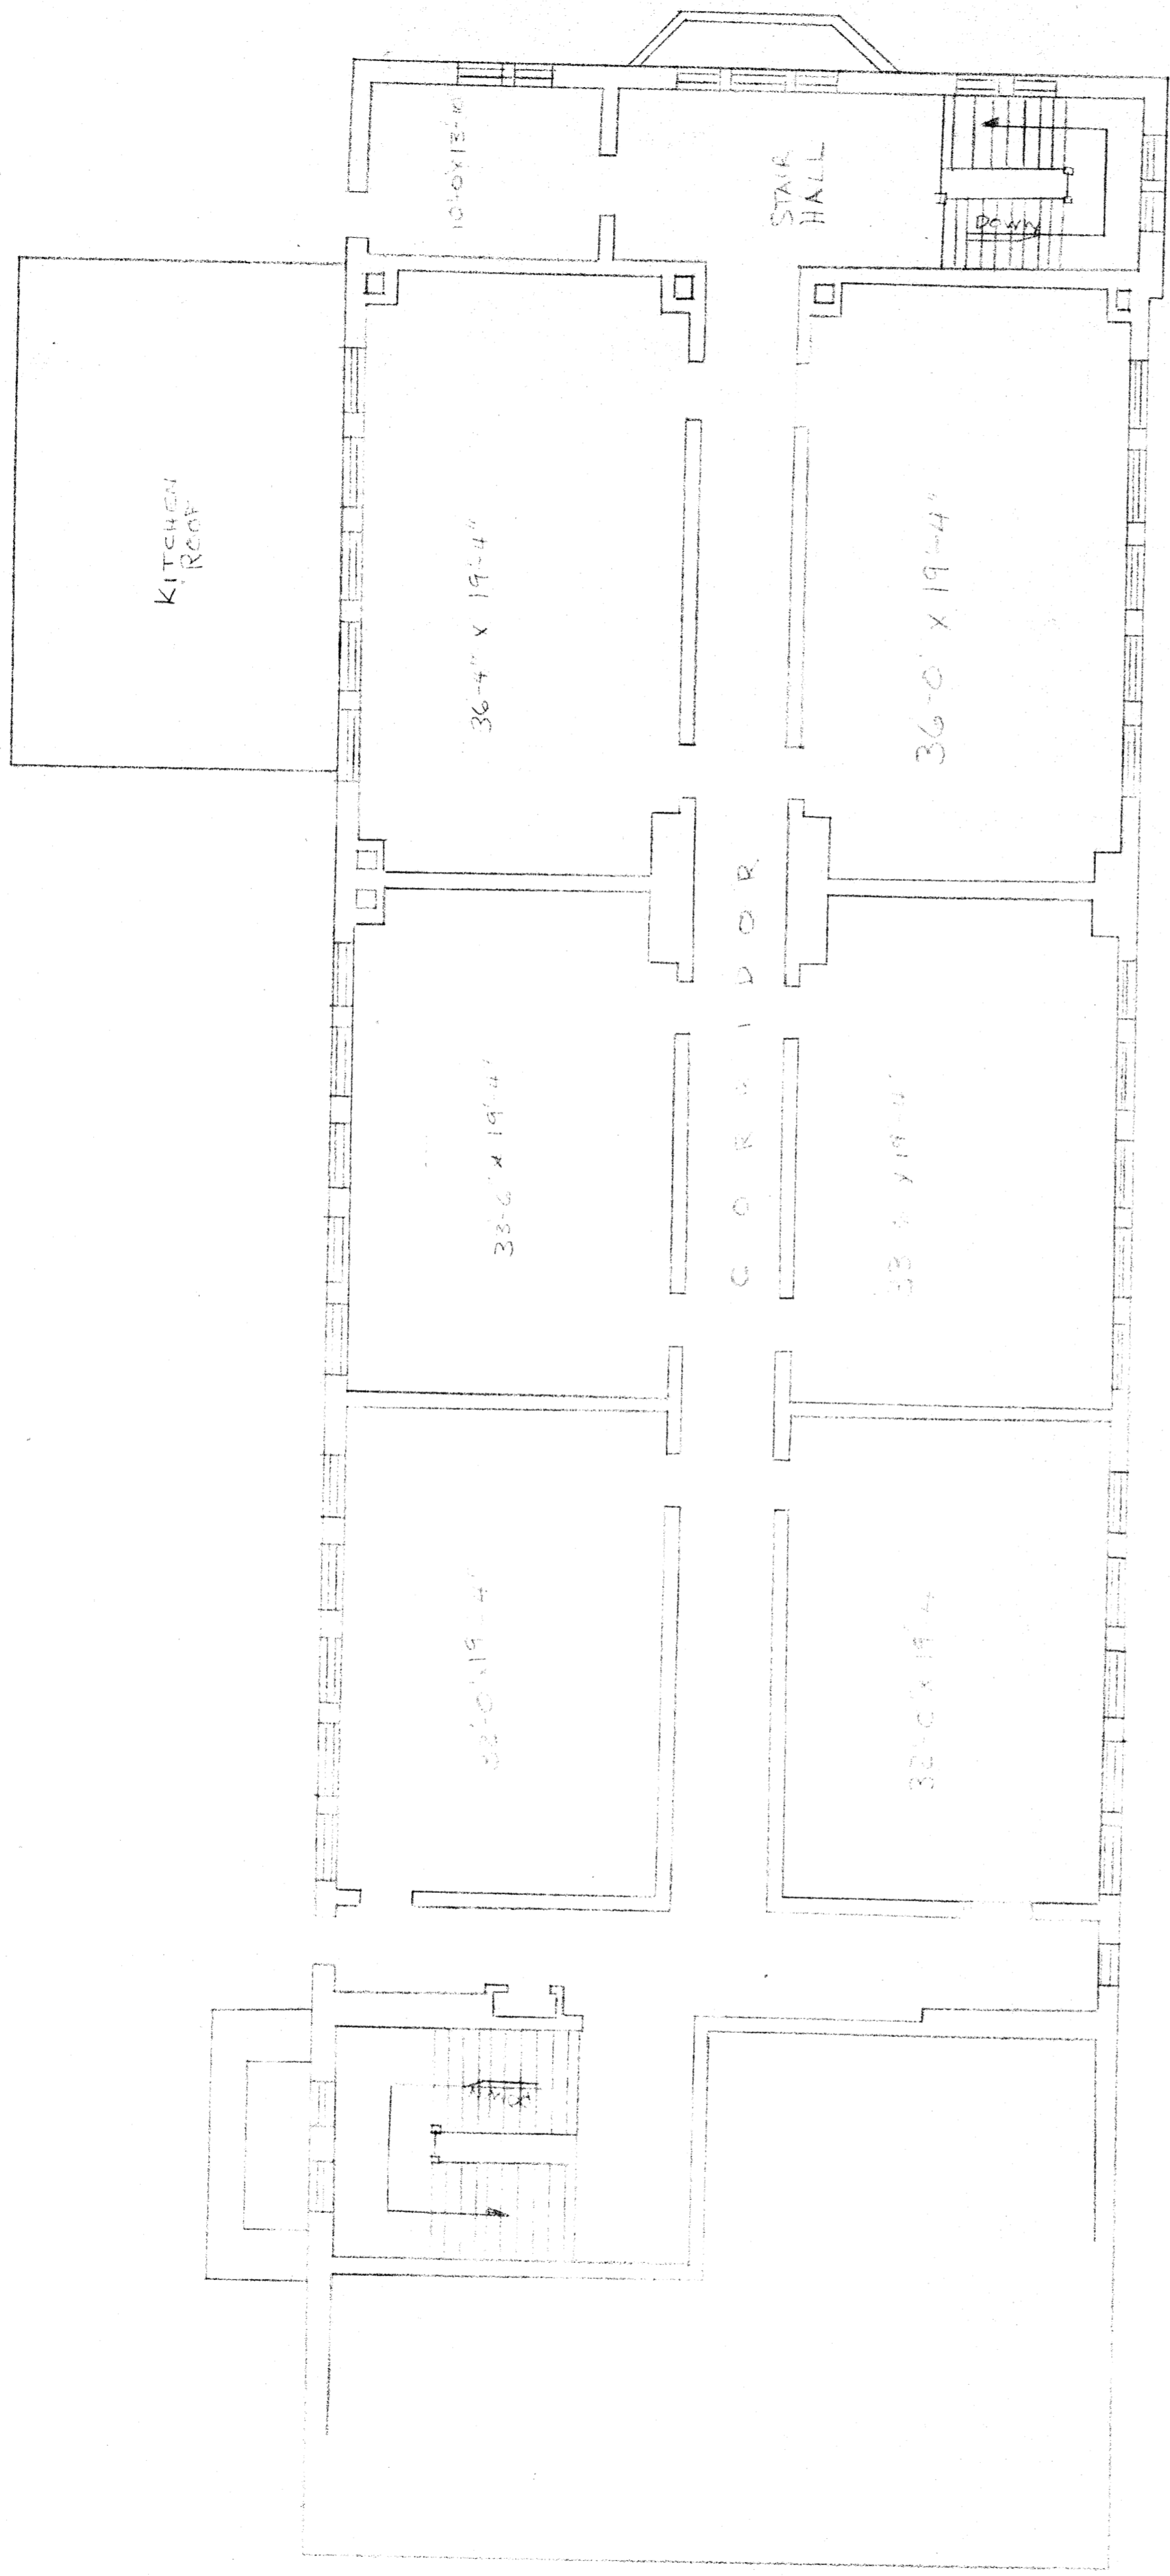

THIRD FLOOR PLAN
SCALE 1/8" = 1'-0"